

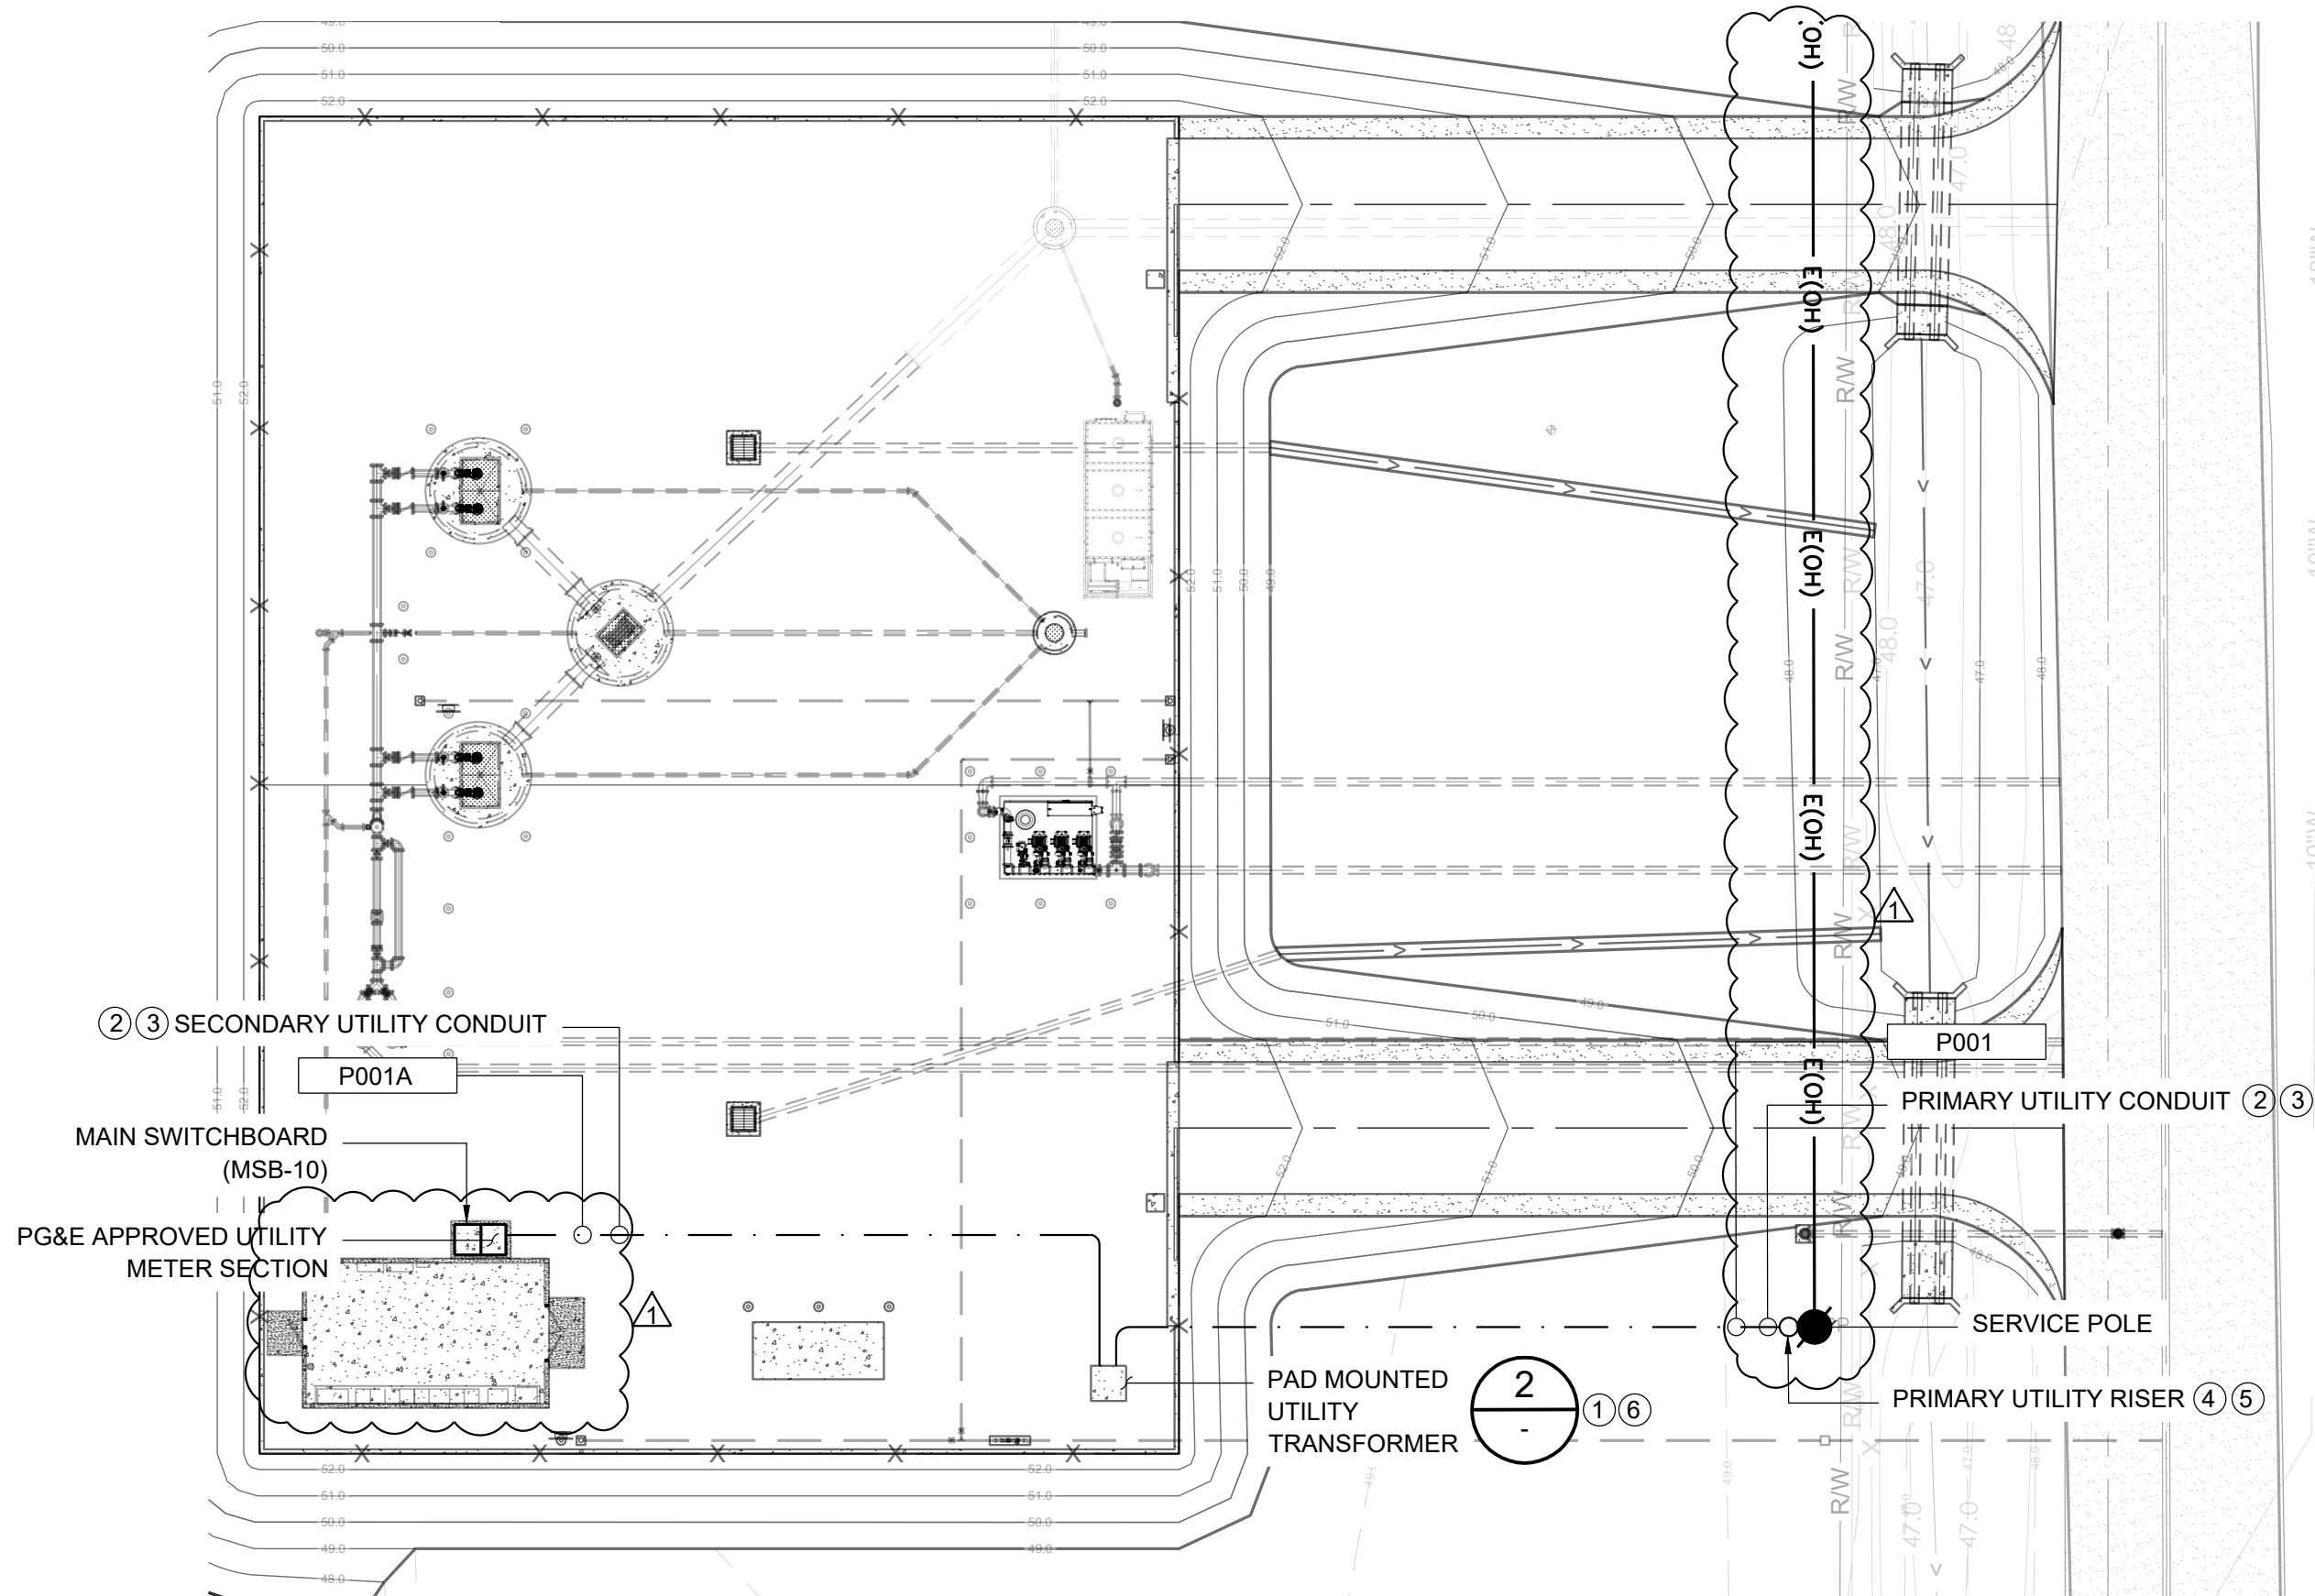
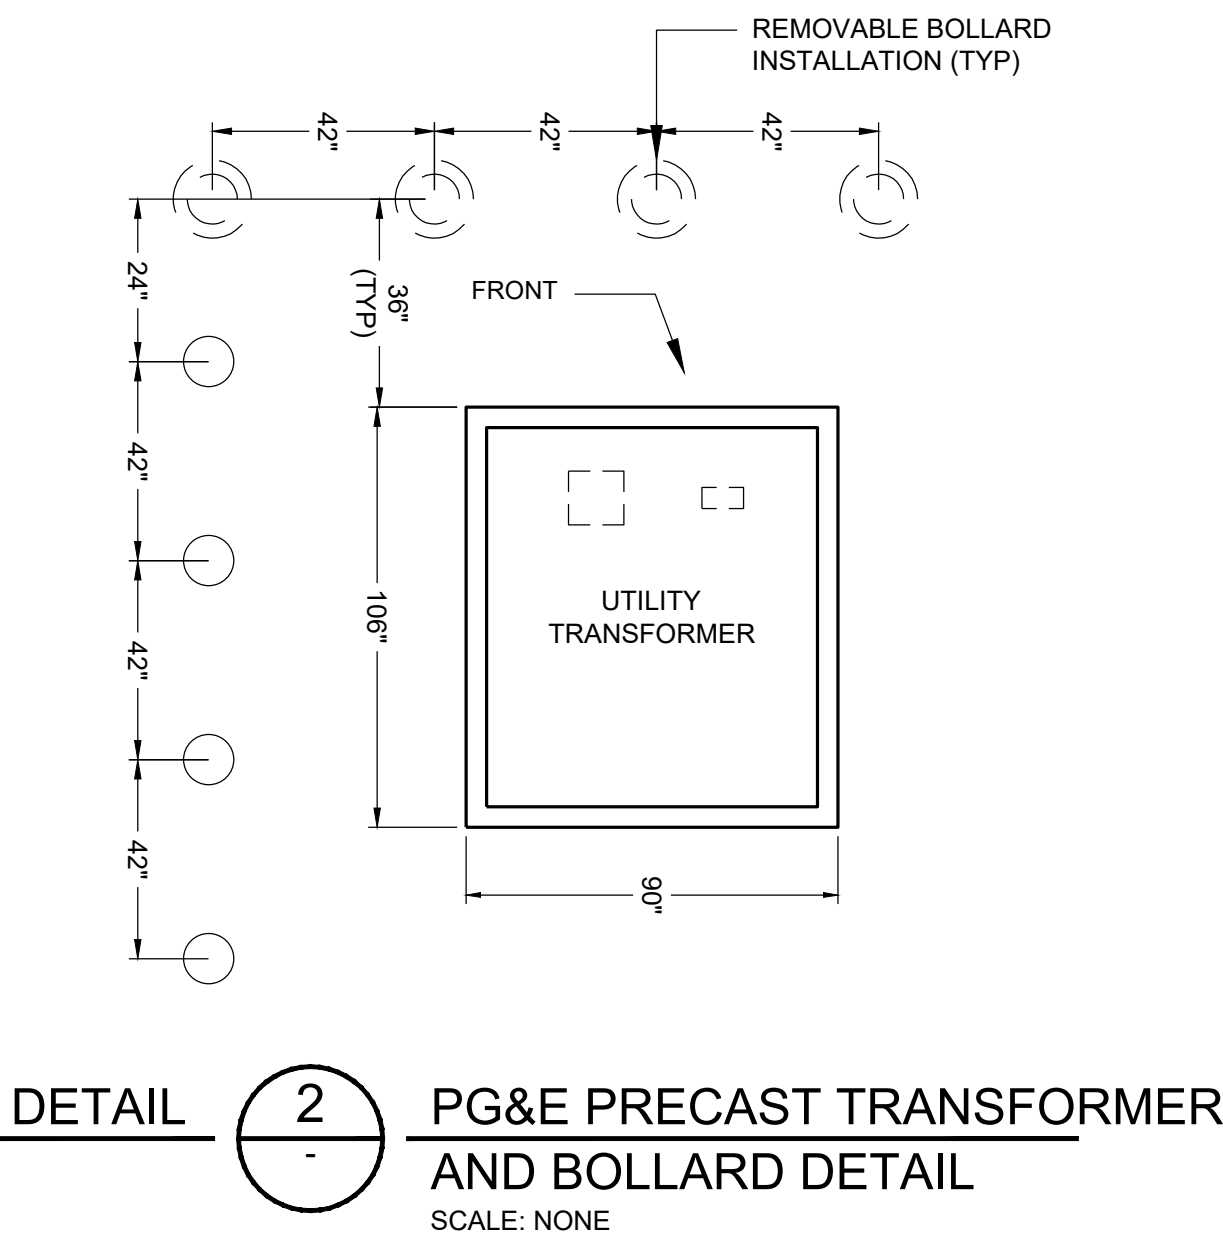


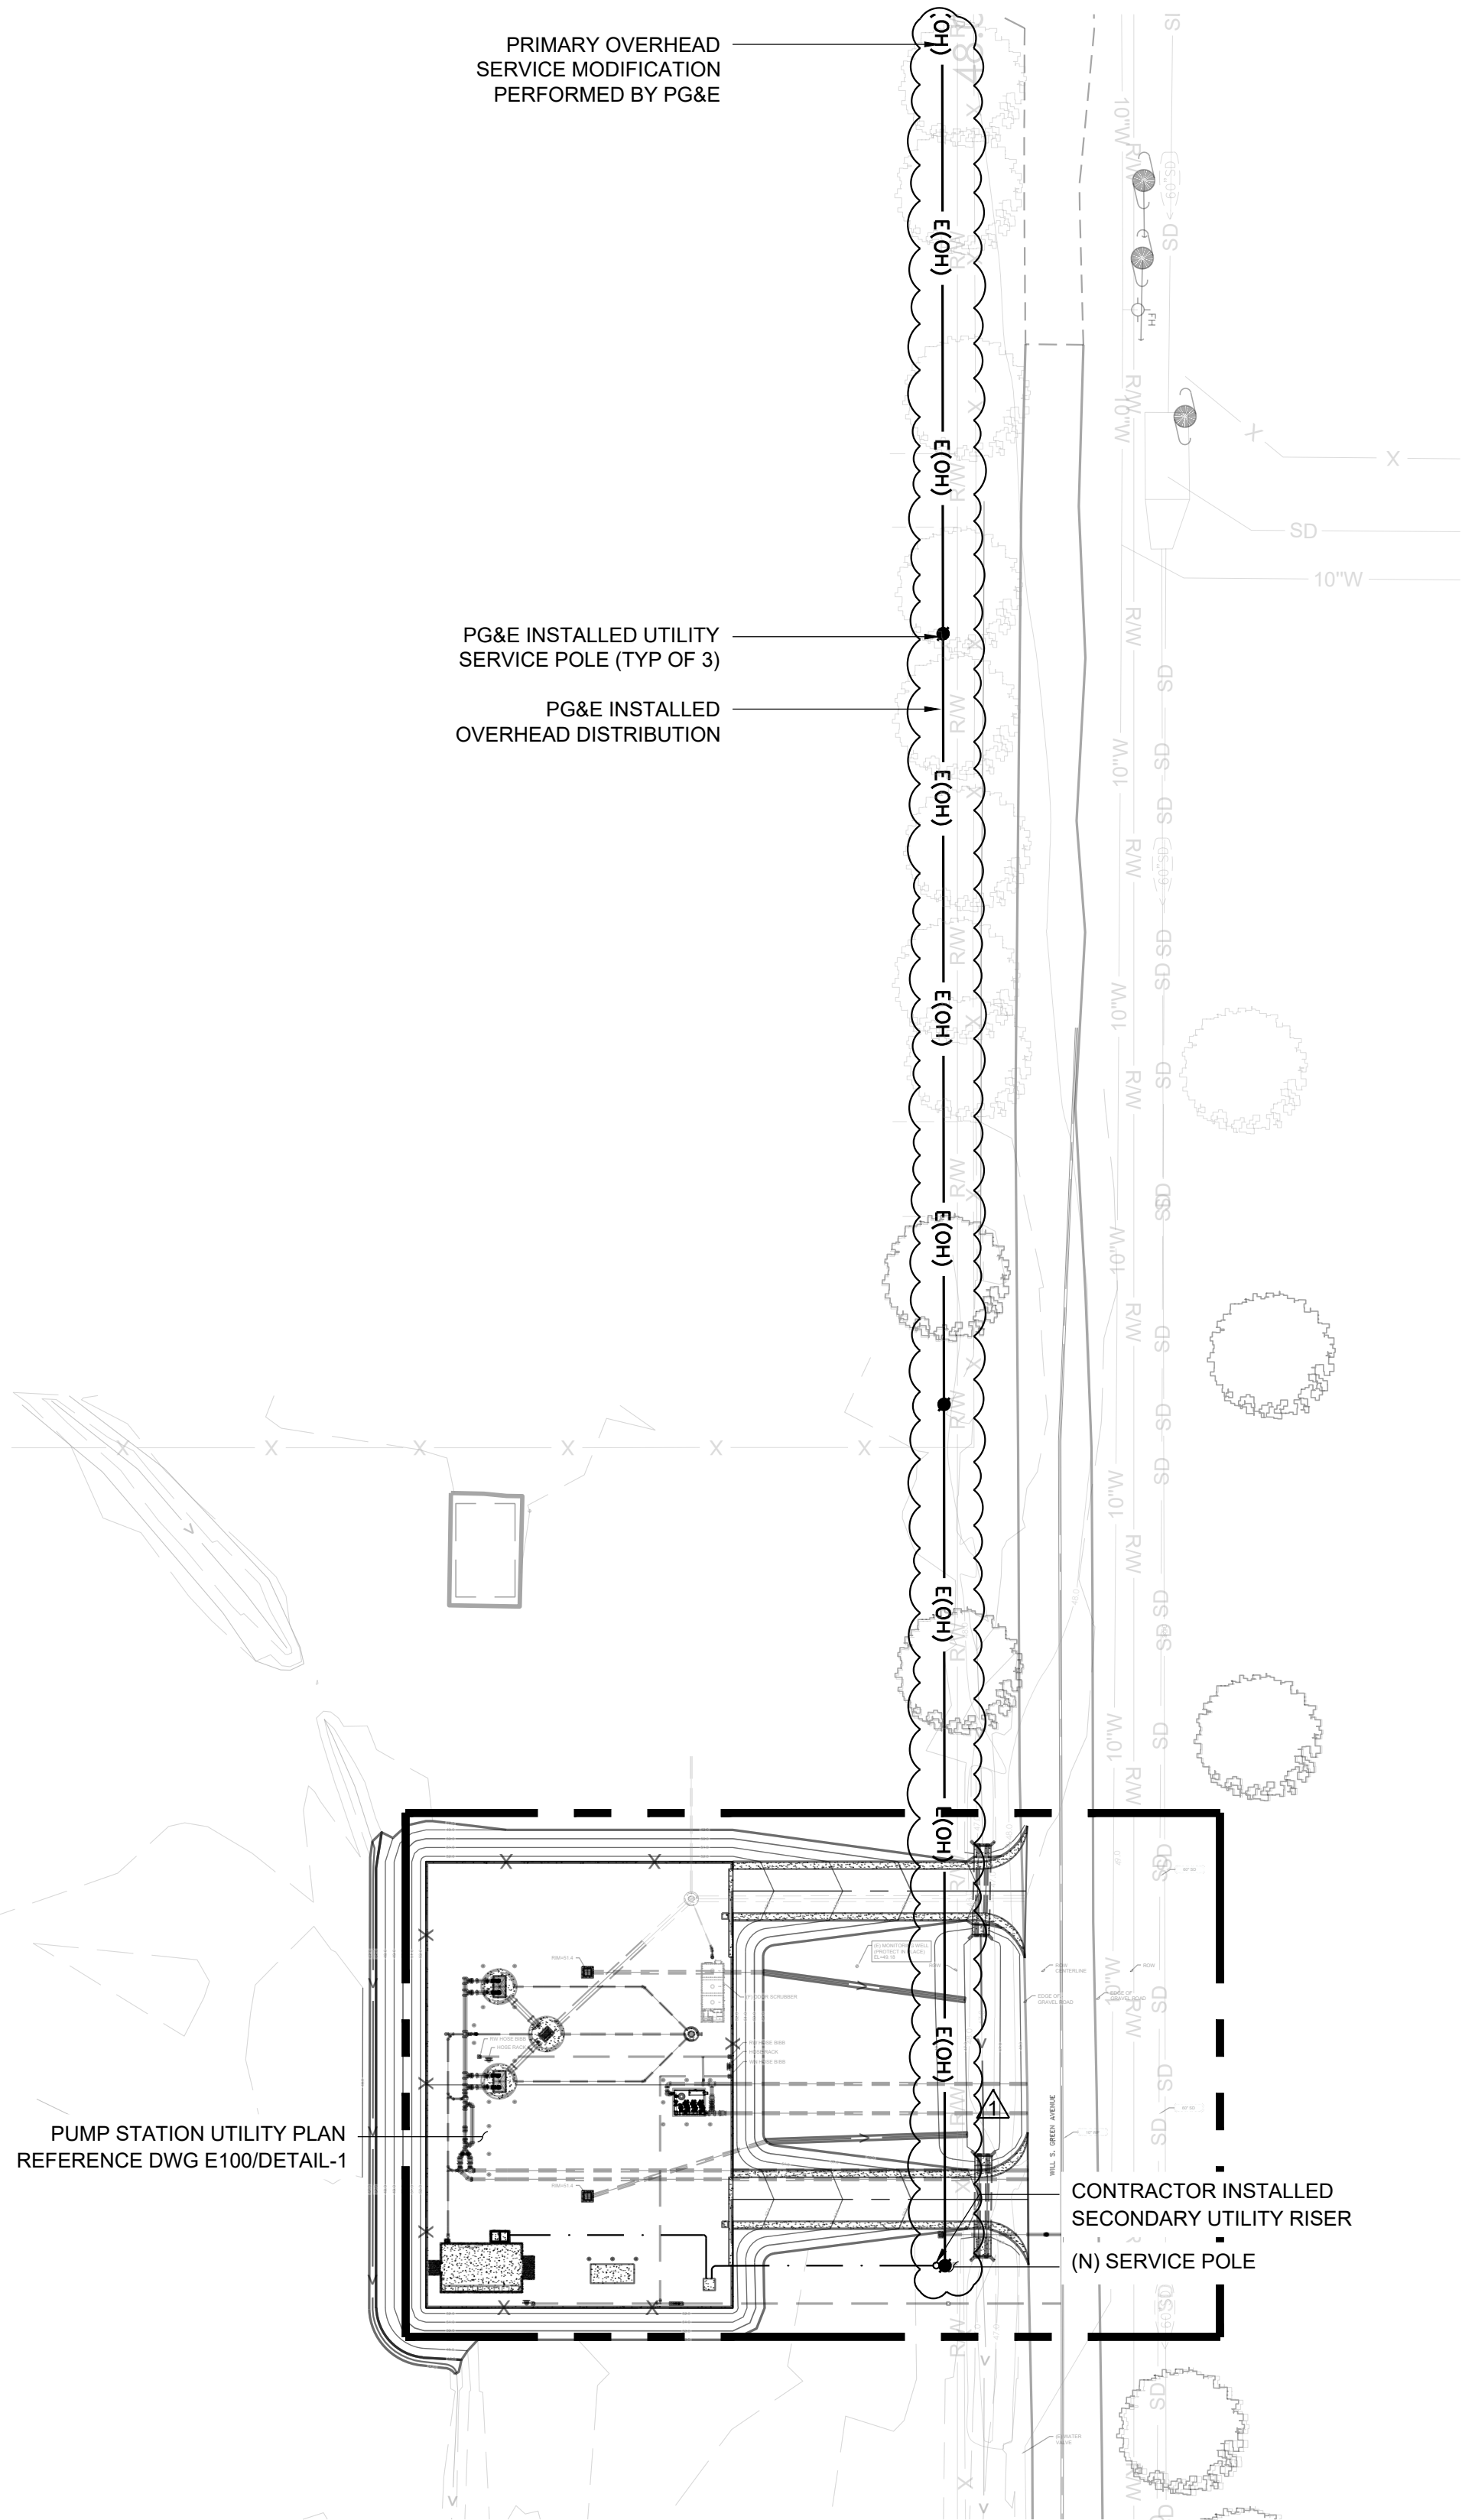


- GENERAL NOTES**
- REFERENCE E001 FOR ADDITIONAL ELECTRICAL GENERAL NOTES.
 - UTILITY EQUIPMENT SHALL CONFORM TO PG&E GREEN BOOK REQUIREMENTS. REFERENCE SPECIFICATION SECTION 16473 FOR ADDITIONAL COORDINATION REQUIREMENTS.
- SHEET NOTES**
- PAD MOUNTED UTILITY TRANSFORMER PROVIDED AND INSTALLED BY PG&E.
 - ALL UNDERGROUND UTILITY CONDUITS SHALL CONFORM TO PG&E GREENBOOK AND STANDARDS.
 - PRIMARY/SECONDARY CONDUITS SHALL BE TRENCHED AND INSTALLED BY THE CONTRACTOR. CONDUCTORS SHALL BE PULLED AND TERMINATED BY PG&E.
 - THE CONTRACTOR SHALL BE RESPONSIBLE FOR THE COMPLETE INSTALLATION, INSPECTIONS AND ACCEPTANCE OF INSTALLATION.
 - FURNISH AND INSTALL UTILITY RISERS IN ACCORDANCE WITH PG&E GREEN BOOK STANDARDS.
 - CONTRACTOR SHALL INSTALL PRE-CAST PAD TRANSFORMER PAD. COORDINATE EXACT PAD LOCATION WITH PG&E AND CITY PRIOR TO INSTALLATION.

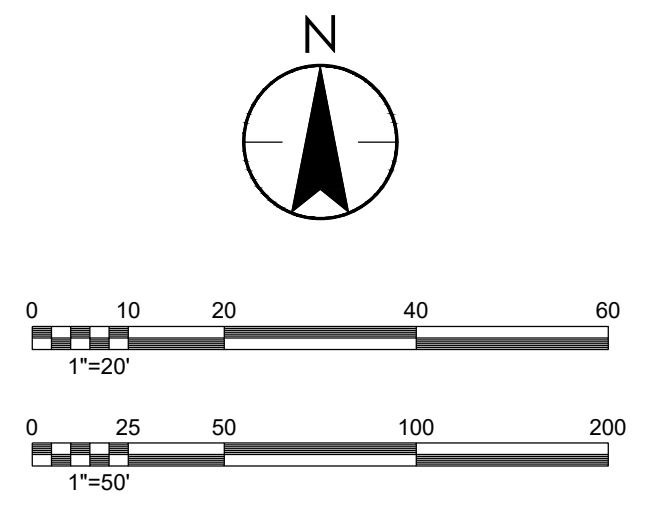


BAR IS ONE INCH AT FULL SCALE			
APRVL	JF		
REVISIONS	ADDENDUM NO.1		
DATE	8/18/2026		
NEXGEN UTILITY MANAGEMENT			
4010 LENNANE DRIVE SACRAMENTO, CA 95834 916.564.8000			
City of Colusa 2026 WILL S. GREEN AVENUE PUMP STATION PROJECT Colusa County, California			
OVERALL UTILITY PLAN			
DATE: 18/08/2026 SCALE: AS NOTED DRAWN BY: JF DESIGNED BY: JF CHECKED BY: JP			
JOB NO: 63.102.C			
DRAWING NO: E100			
34 OF 45 SHEETS			


C:\Projects\Active\COLU23-001 - WWP Reliability Project\AutoCAD\ACT\WGSA\E100 OVERALL UTILITY PLAN - ADD1.dwg 8/18/26 9:30am jaramenj

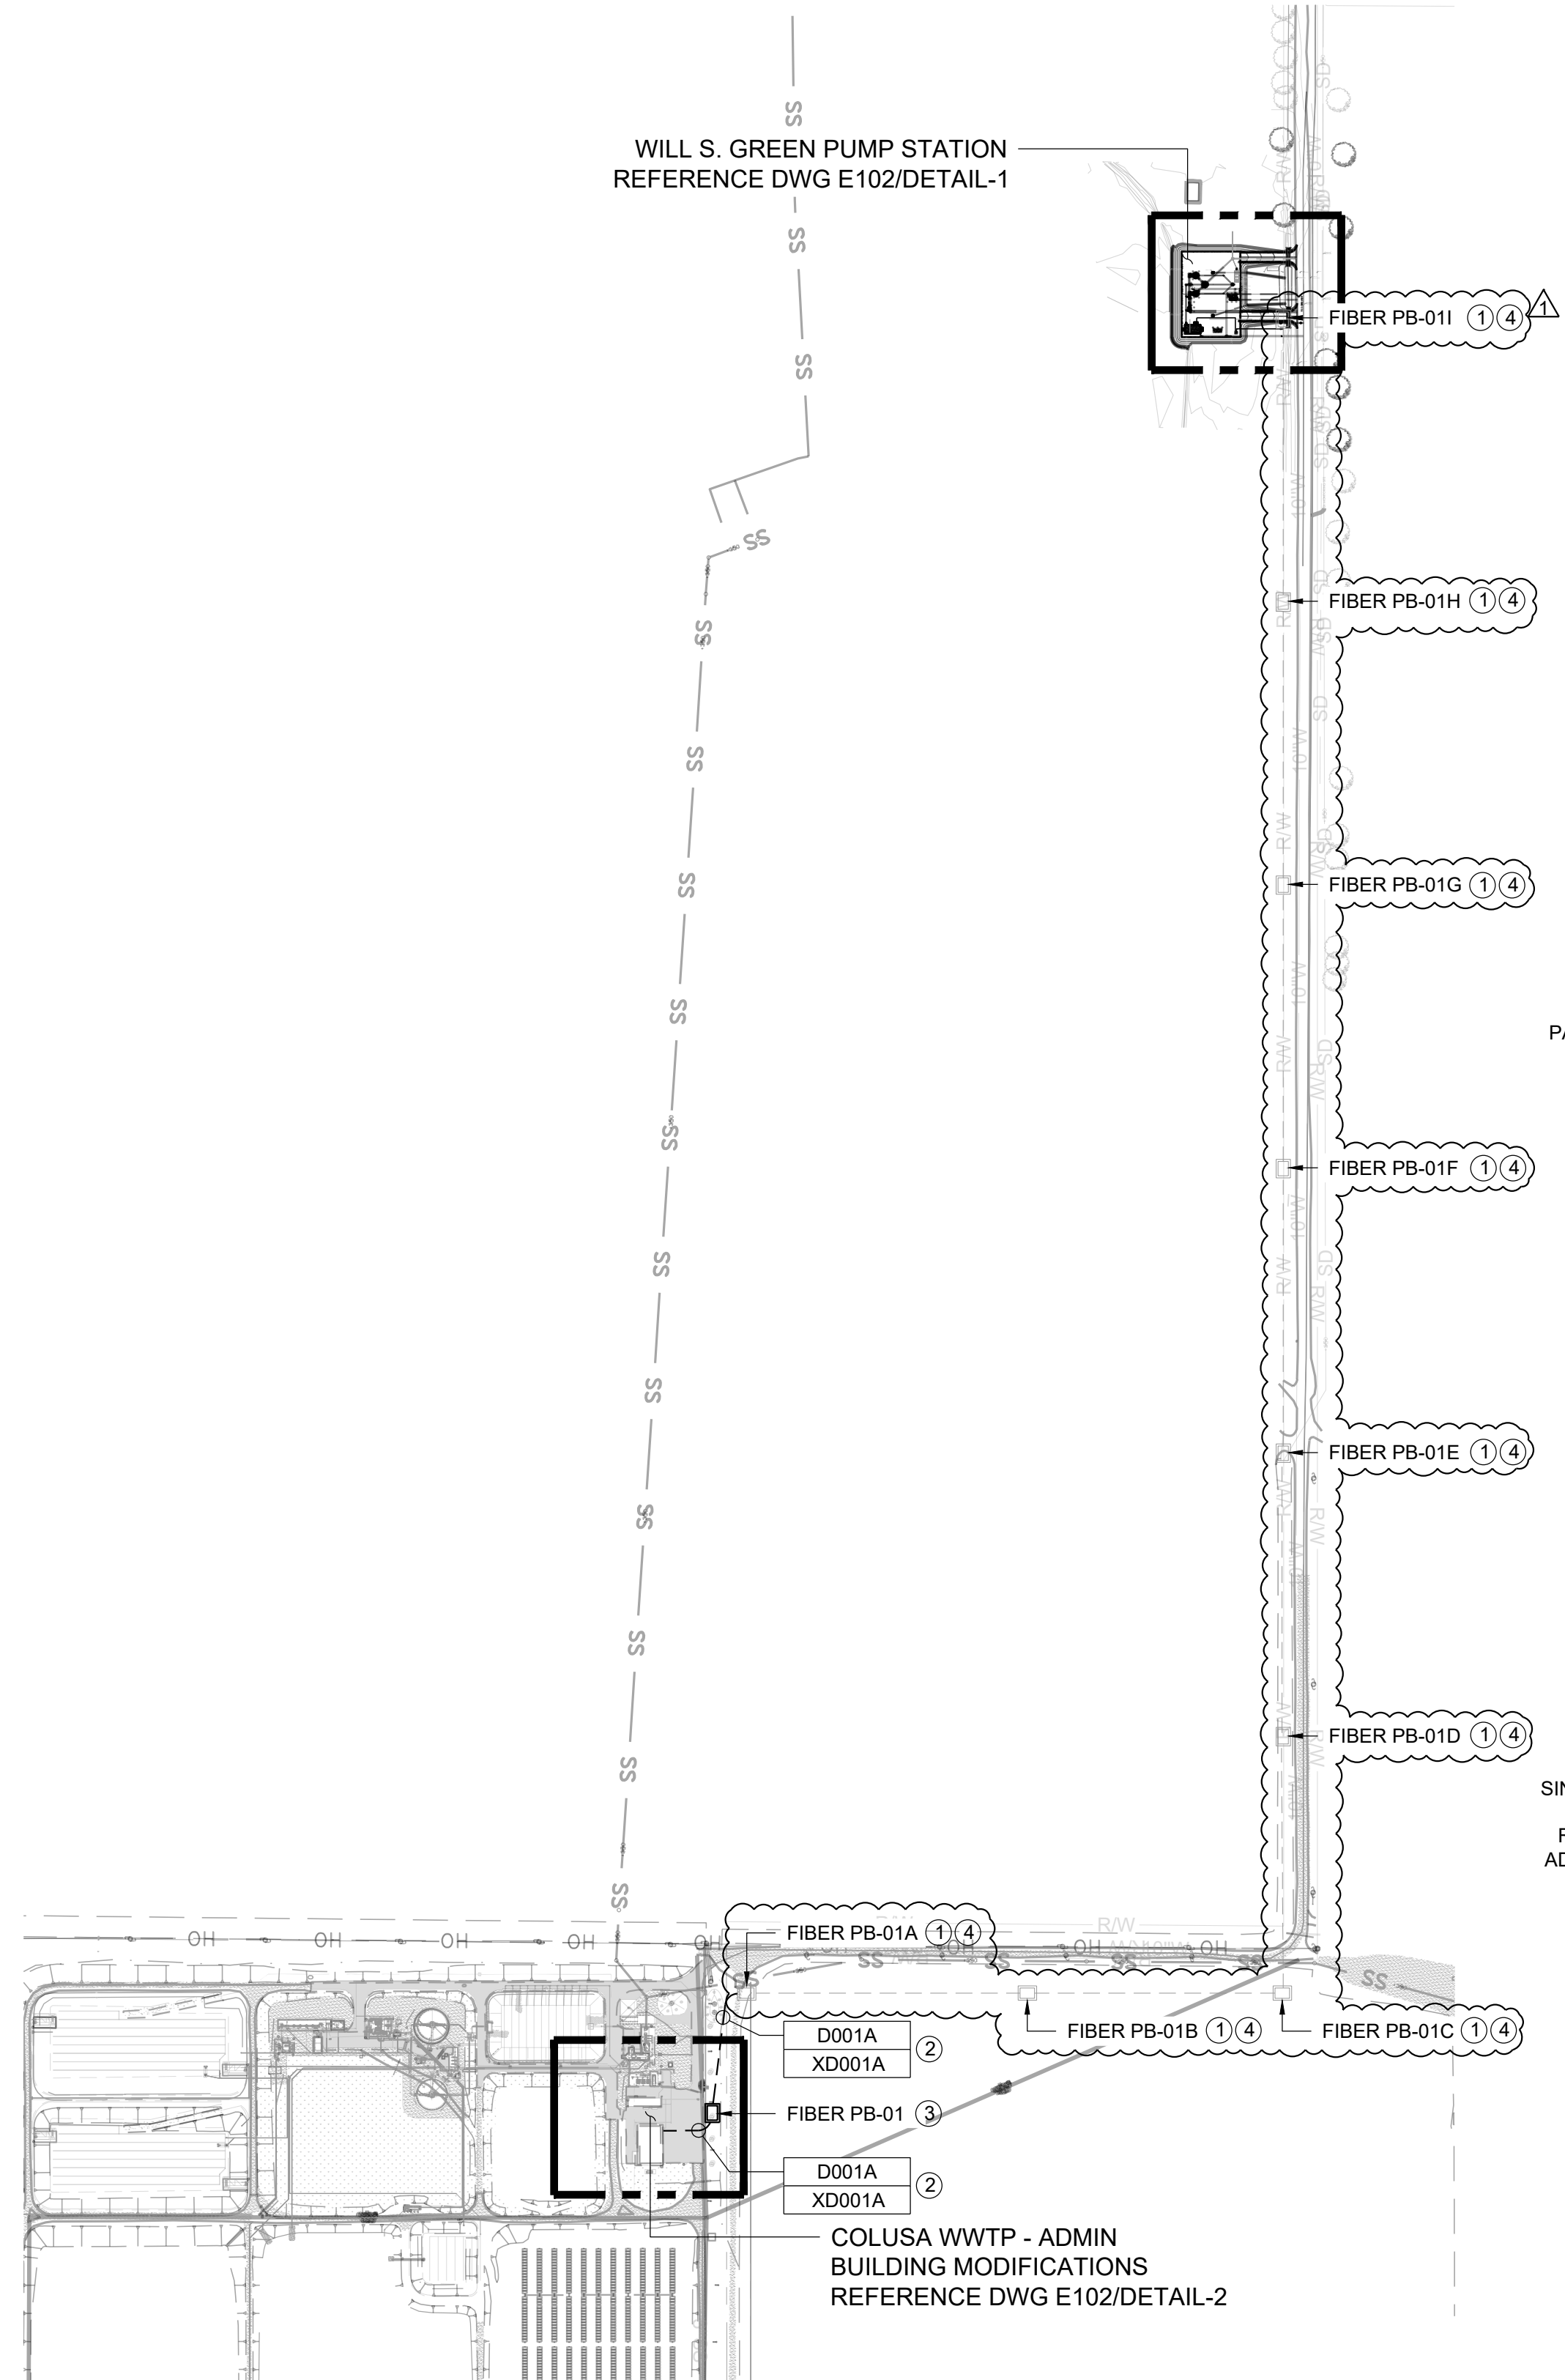

OVERALL COMMUNICATION PLAN
SCALE: 1" = 250'-0"

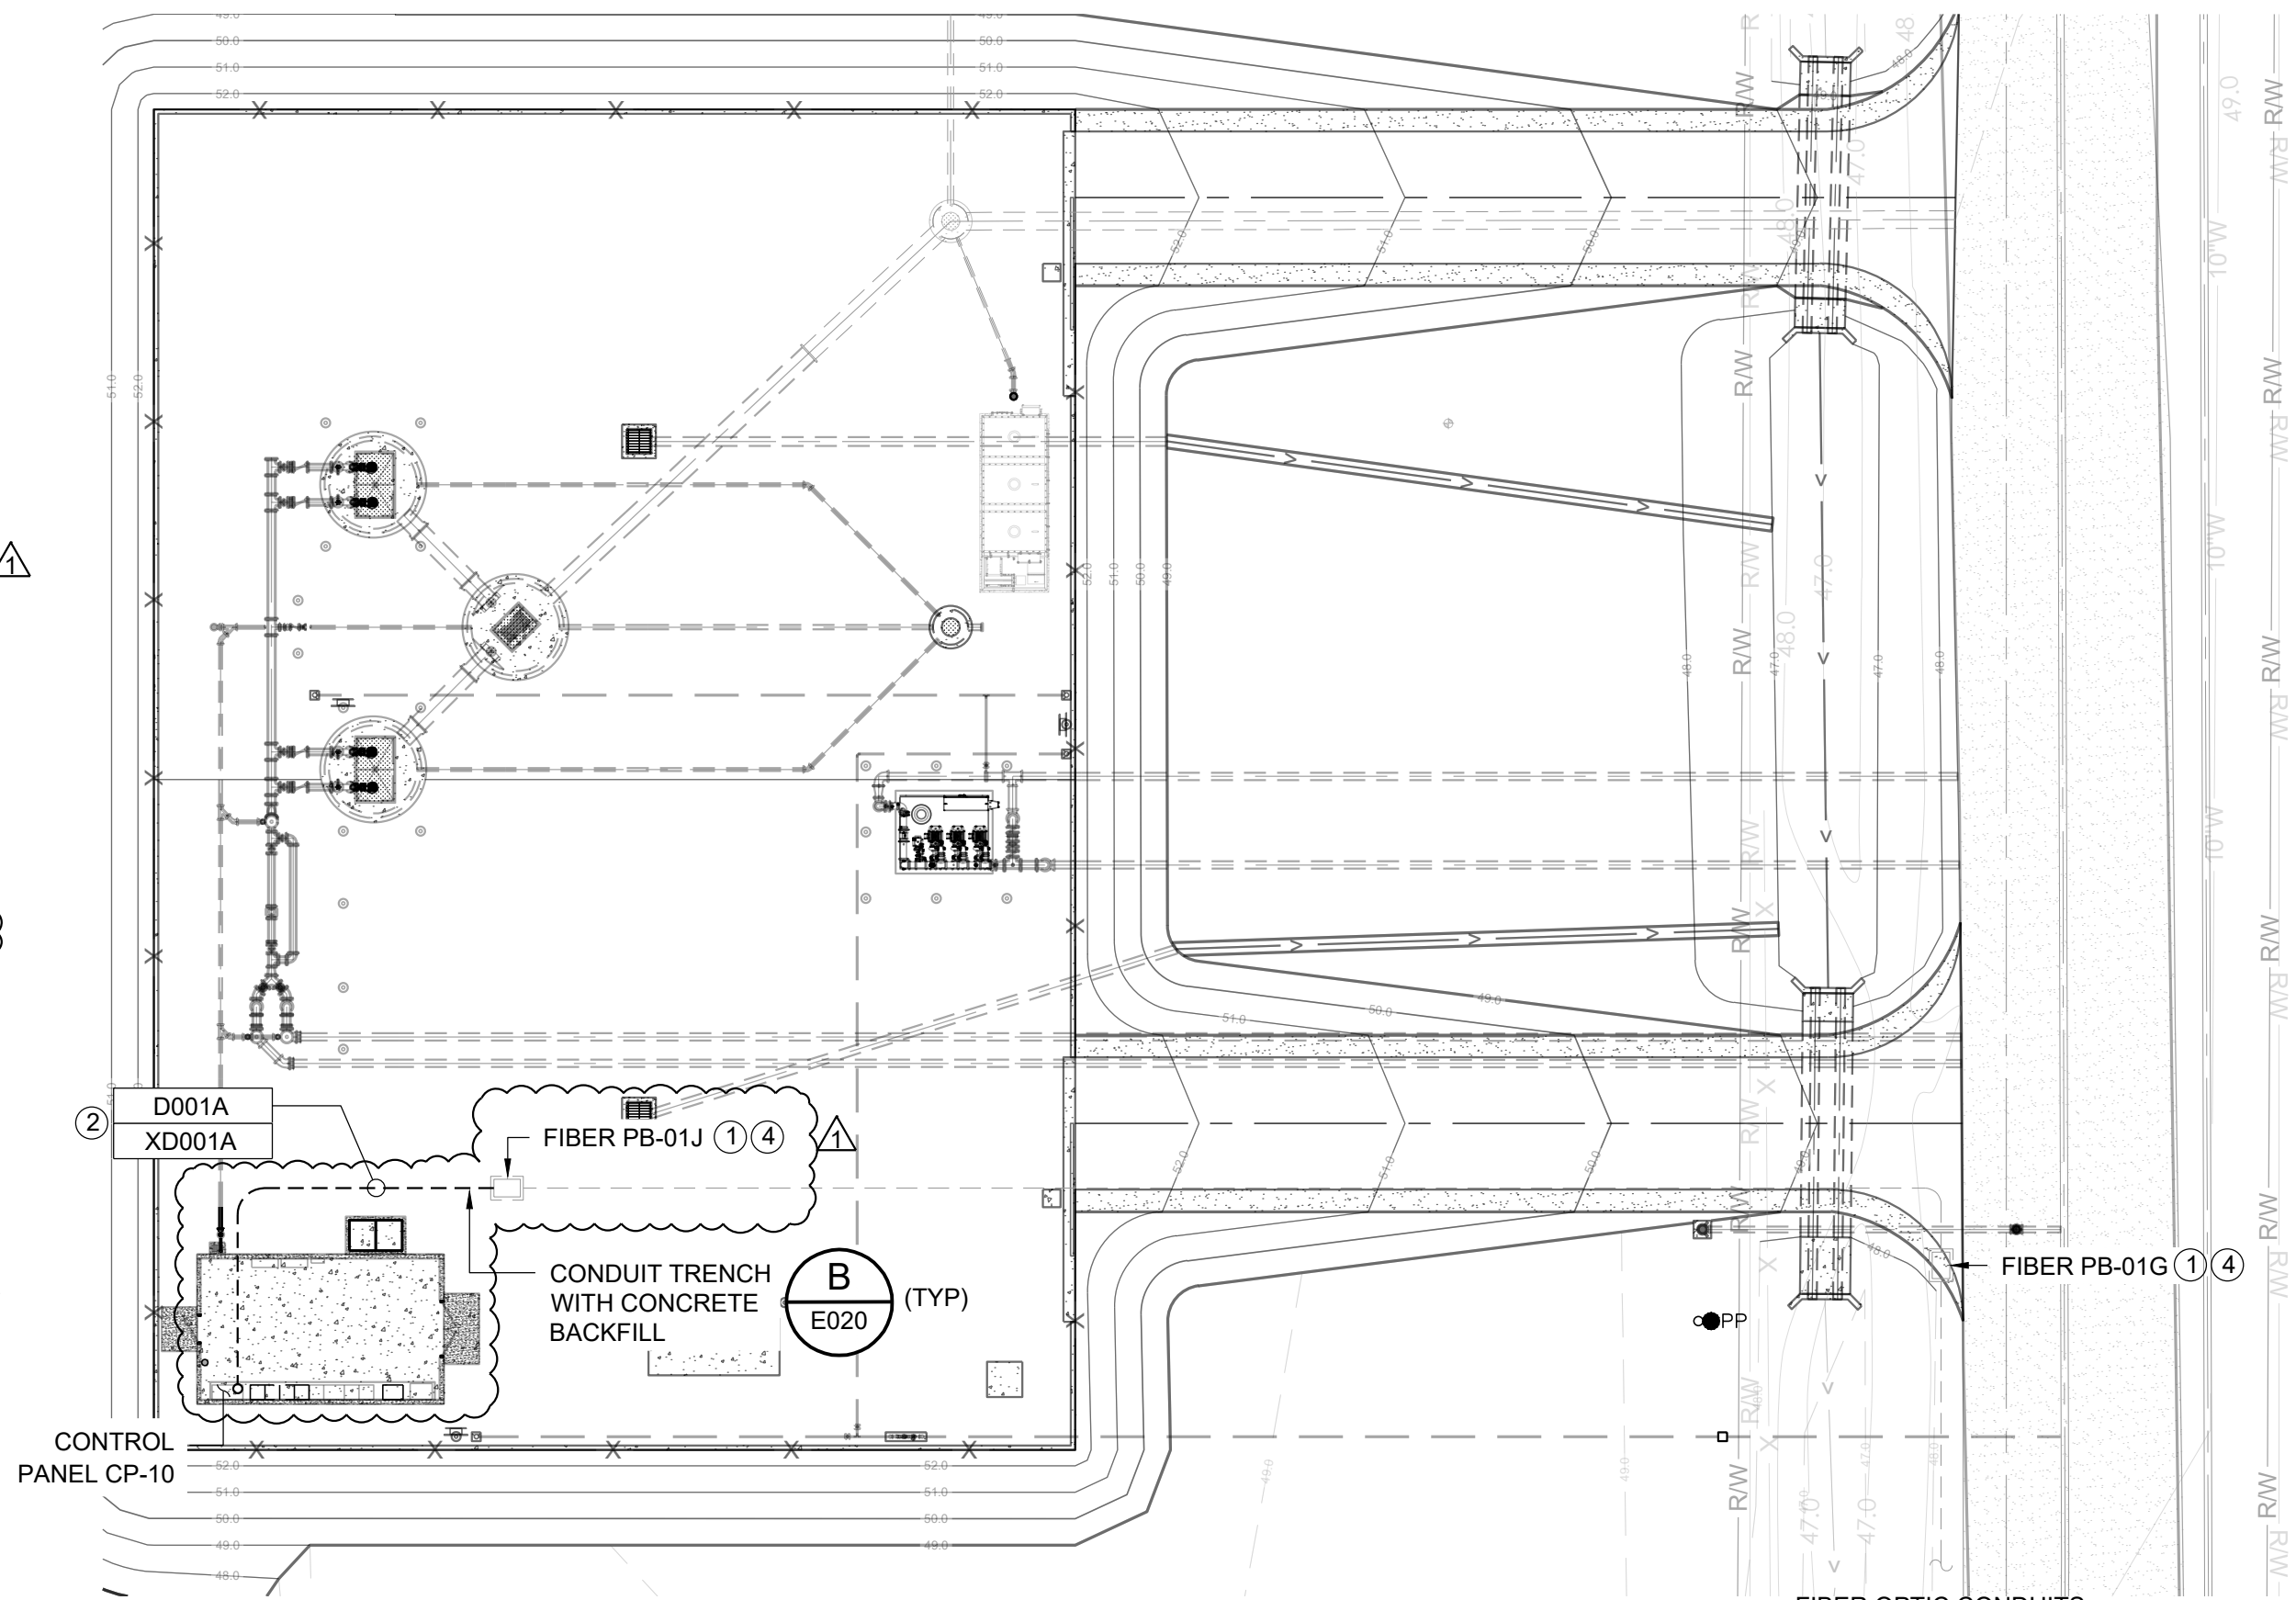

VIEW 1 WILL S. GREEN PUMP STATION
COMMUNICATION PLAN
SCALE: 1" = 20'-0"

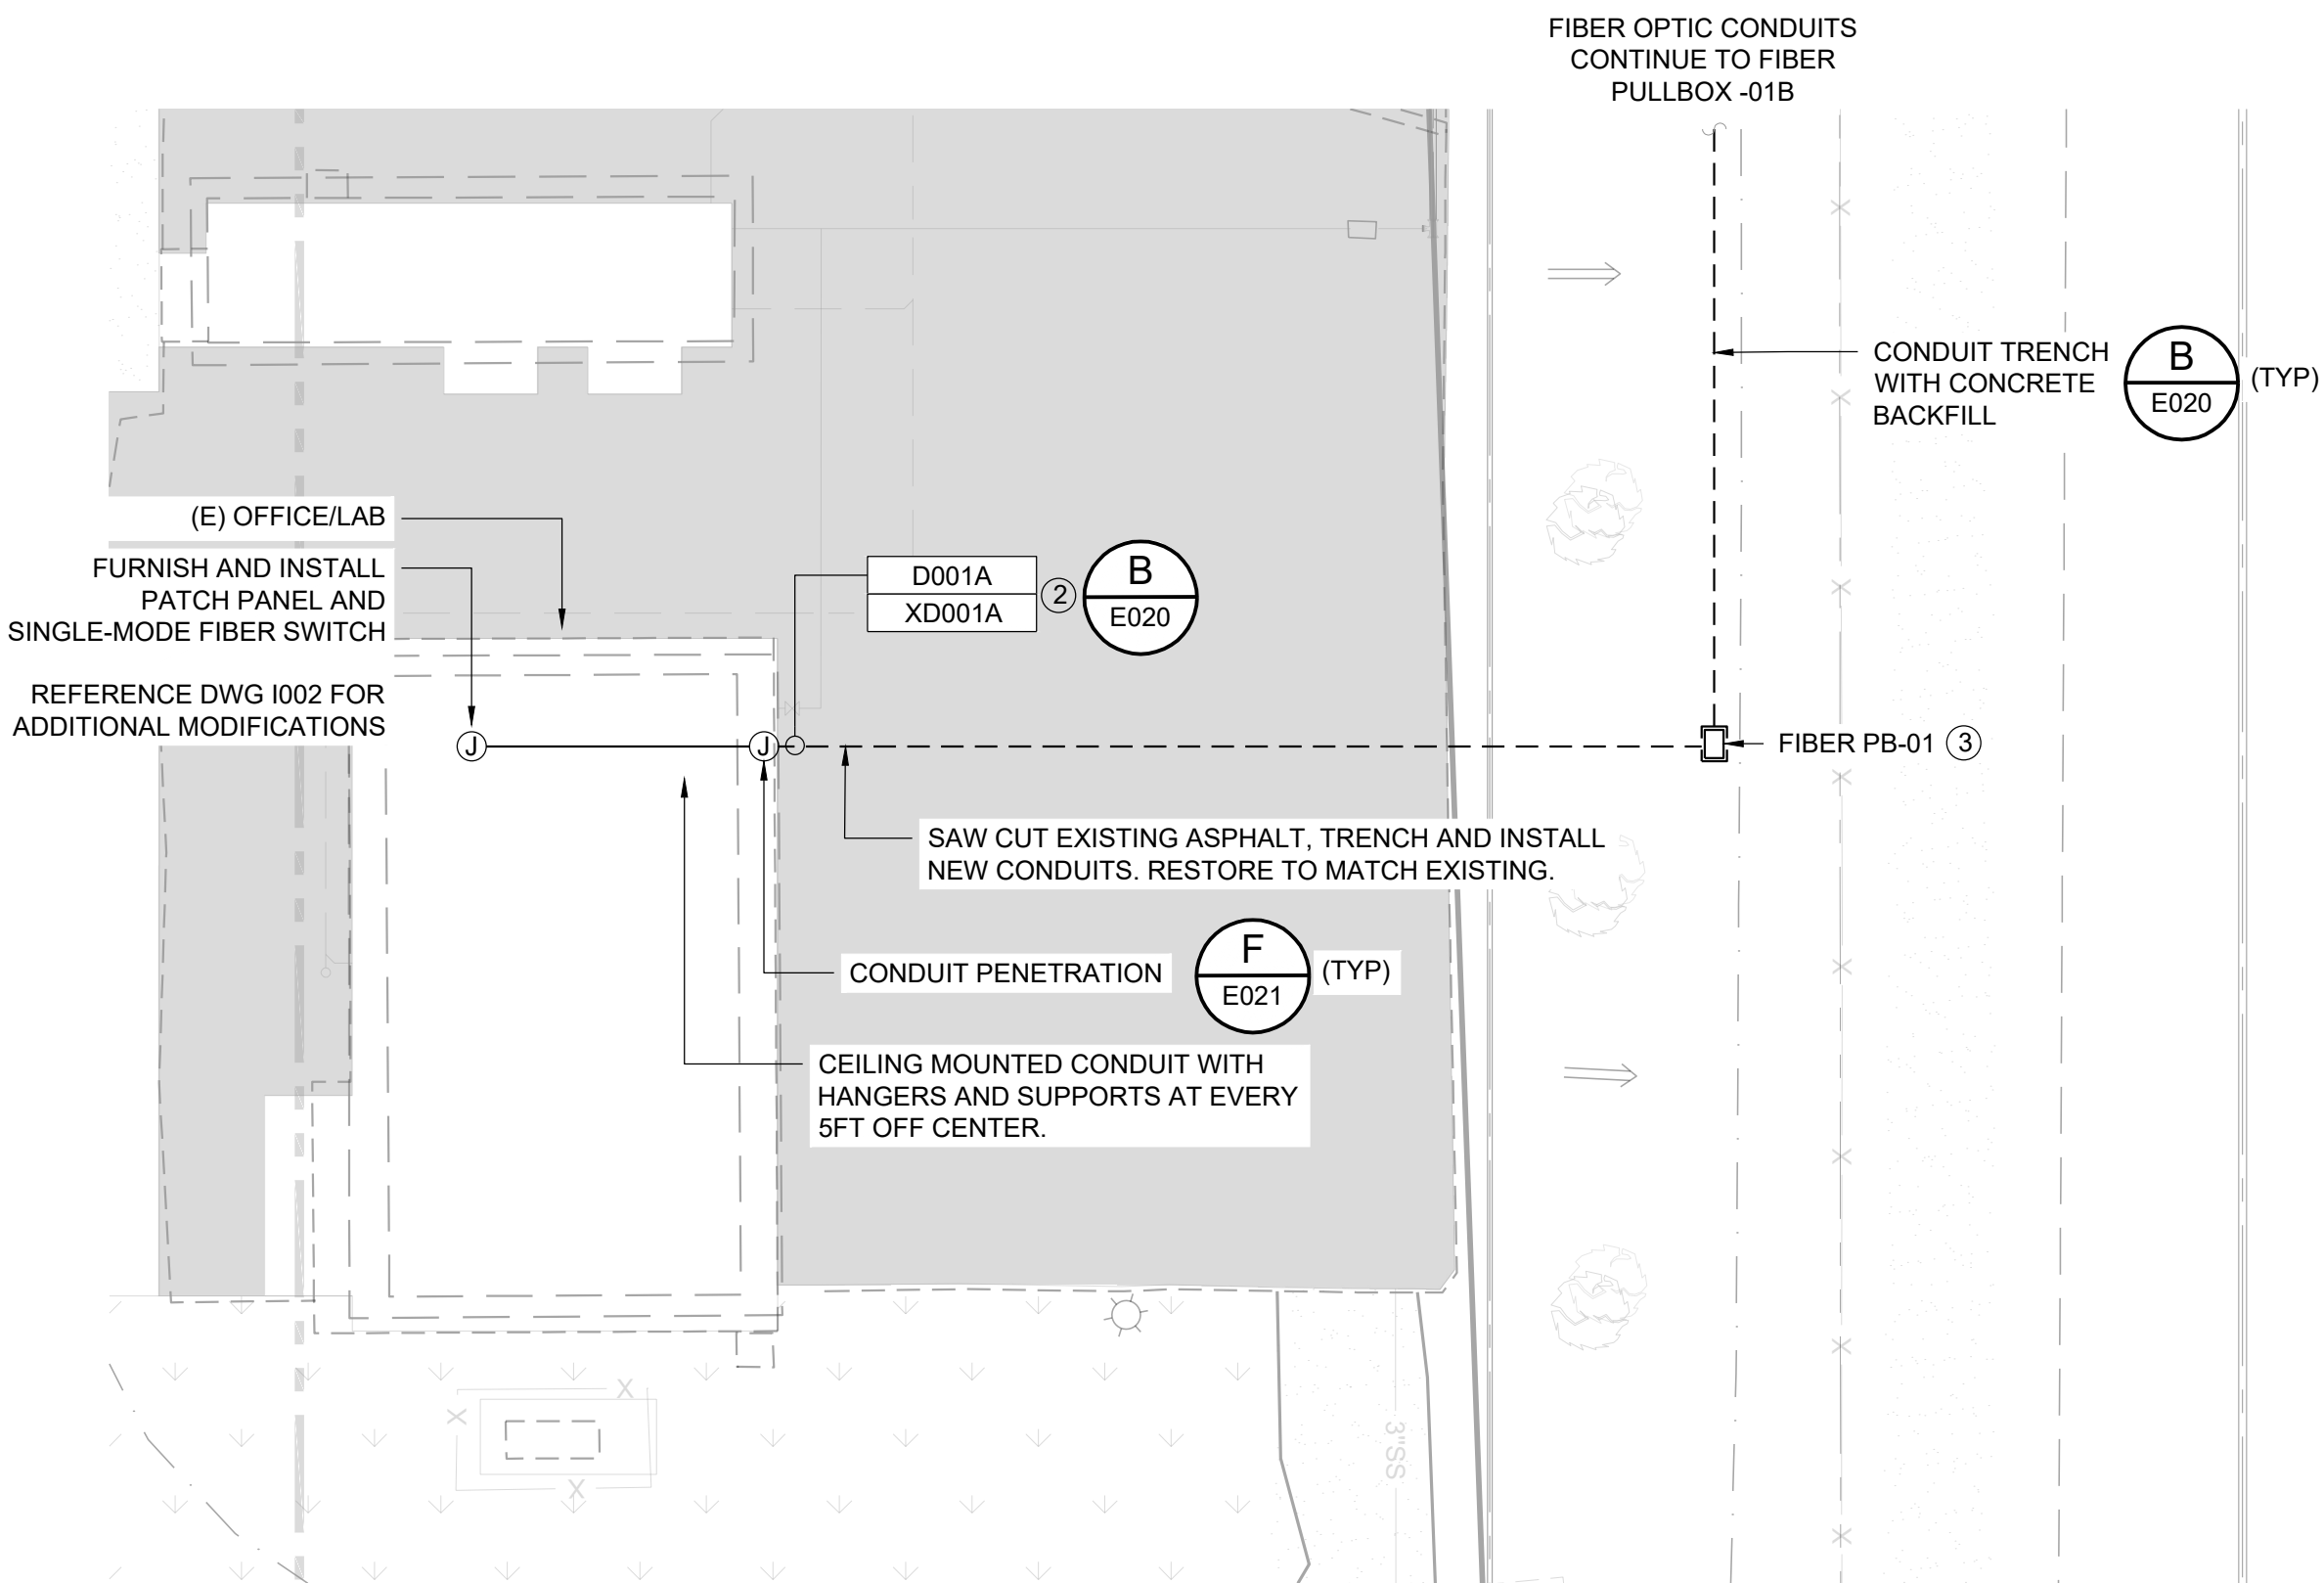

VIEW 2 COLUSA WWTP ADMIN BUILDING
COMMUNICATION PLAN
SCALE: 1" = 20'-0"

GENERAL NOTES

- REFERENCE E001 FOR ADDITIONAL ELECTRICAL GENERAL NOTES.
- AREA CLASSIFICATION SHALL APPLY UNLESS OTHERWISE NOTED ON THE PLANS AND SPECIFICATIONS.
- MAINTAIN A MINIMUM OF 12" SEPARATIONS BETWEEN FIBER CONDUITS AND PROCESS PIPING.

SHEET NOTES

- FIBER OPTIC PULL BOXES AND CONDUITS TO BE INSTALLED BY OTHERS. THE CONTRACTOR SHALL PULL, TESTING, AND INSTALL NEW SINGLE MODE FIBER OPTIC VIA 2" CONDUIT BETWEEN WILL S. GREEN PUMP STATION AND COLUSA WWTP.
- INSTALL (2) 2" CONDUIT BETWEEN FIBER OPTIC PUL BOX LOCAL CONTROL PANEL AT WILL S. GREEN AND ADMIN ROOM NETWORK RACK.
- INSTALL (N) H20 RATED 24"X36" MIN. PULL BOX TO MATCH EXISTING. PROVIDE PULL BOX WITH STEEL LID.
- MANDREL EXISTING CONDUITS BETWEEN PULL BOXES AND CONFIRM THERE ARE NO ISSUE WITH CONDUIT PRIOR TO INSTALLING FIBER OPTIC CABLES.

BAR IS ONE INCH
AT FULL SCALE

APR'L

JF

REVISIONS

ADDENDUM NO.1

DATE

8/18/2026

DATE

8/18/2026


DATE

8/18/2026

DATE

8/18/2026

NEXGEN UTILITY MANAGEMENT
4010 LENNANE DRIVE
SACRAMENTO, CA 95834
916.564.8000

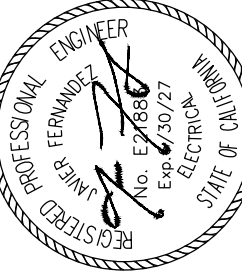

City of Colusa
2026 WILL S. GREEN AVENUE
PUMP STATION PROJECT
Colusa County, California

OVERALL
COMMUNICATION PLAN

DATE: 18/08/2026
SCALE: AS NOTED
DRAWN BY: JF
DESIGNED BY: JF
CHECKED BY: JP

JOB NO: 63.102.C

DRAWING NO:
E102

36 OF 45 SHEETS